


OWNER: SPH MBO 1000 Toa Payoh North NWS (Antre S 318994)	
PROJECT: CANON FOCUS ON FASHION 2010 02 APRIL - 02 MAY 2010	
LOCATION: FORUM SHOPPING MALL OUT-DOOR AREA ORCHARD ROAD	
LICENSED ELECTRICAL WORKER: Hosaini Bin Rasid LEW No: 7/079776 <i>1403/2010</i>	
CONTRACTOR: OGL ASIA PTE LTD 134 JOO SENG ROAD #01-03 NOBEL DESIGN HOUSE SINGAPORE 368359 TEL : 6284 9011 FAX : 6284 9052	
DRAWING: ELECTRICAL SCHEMATIC SINGLE LINE DIAGRAM	
DRAWN: MR. LOI	SCALE NTS
CHECKED: MR. NG	DATE: 11 MARCH 2010
DRAWING NO.: CANON @ FORUM SHOPPING MALL 10/ E01	

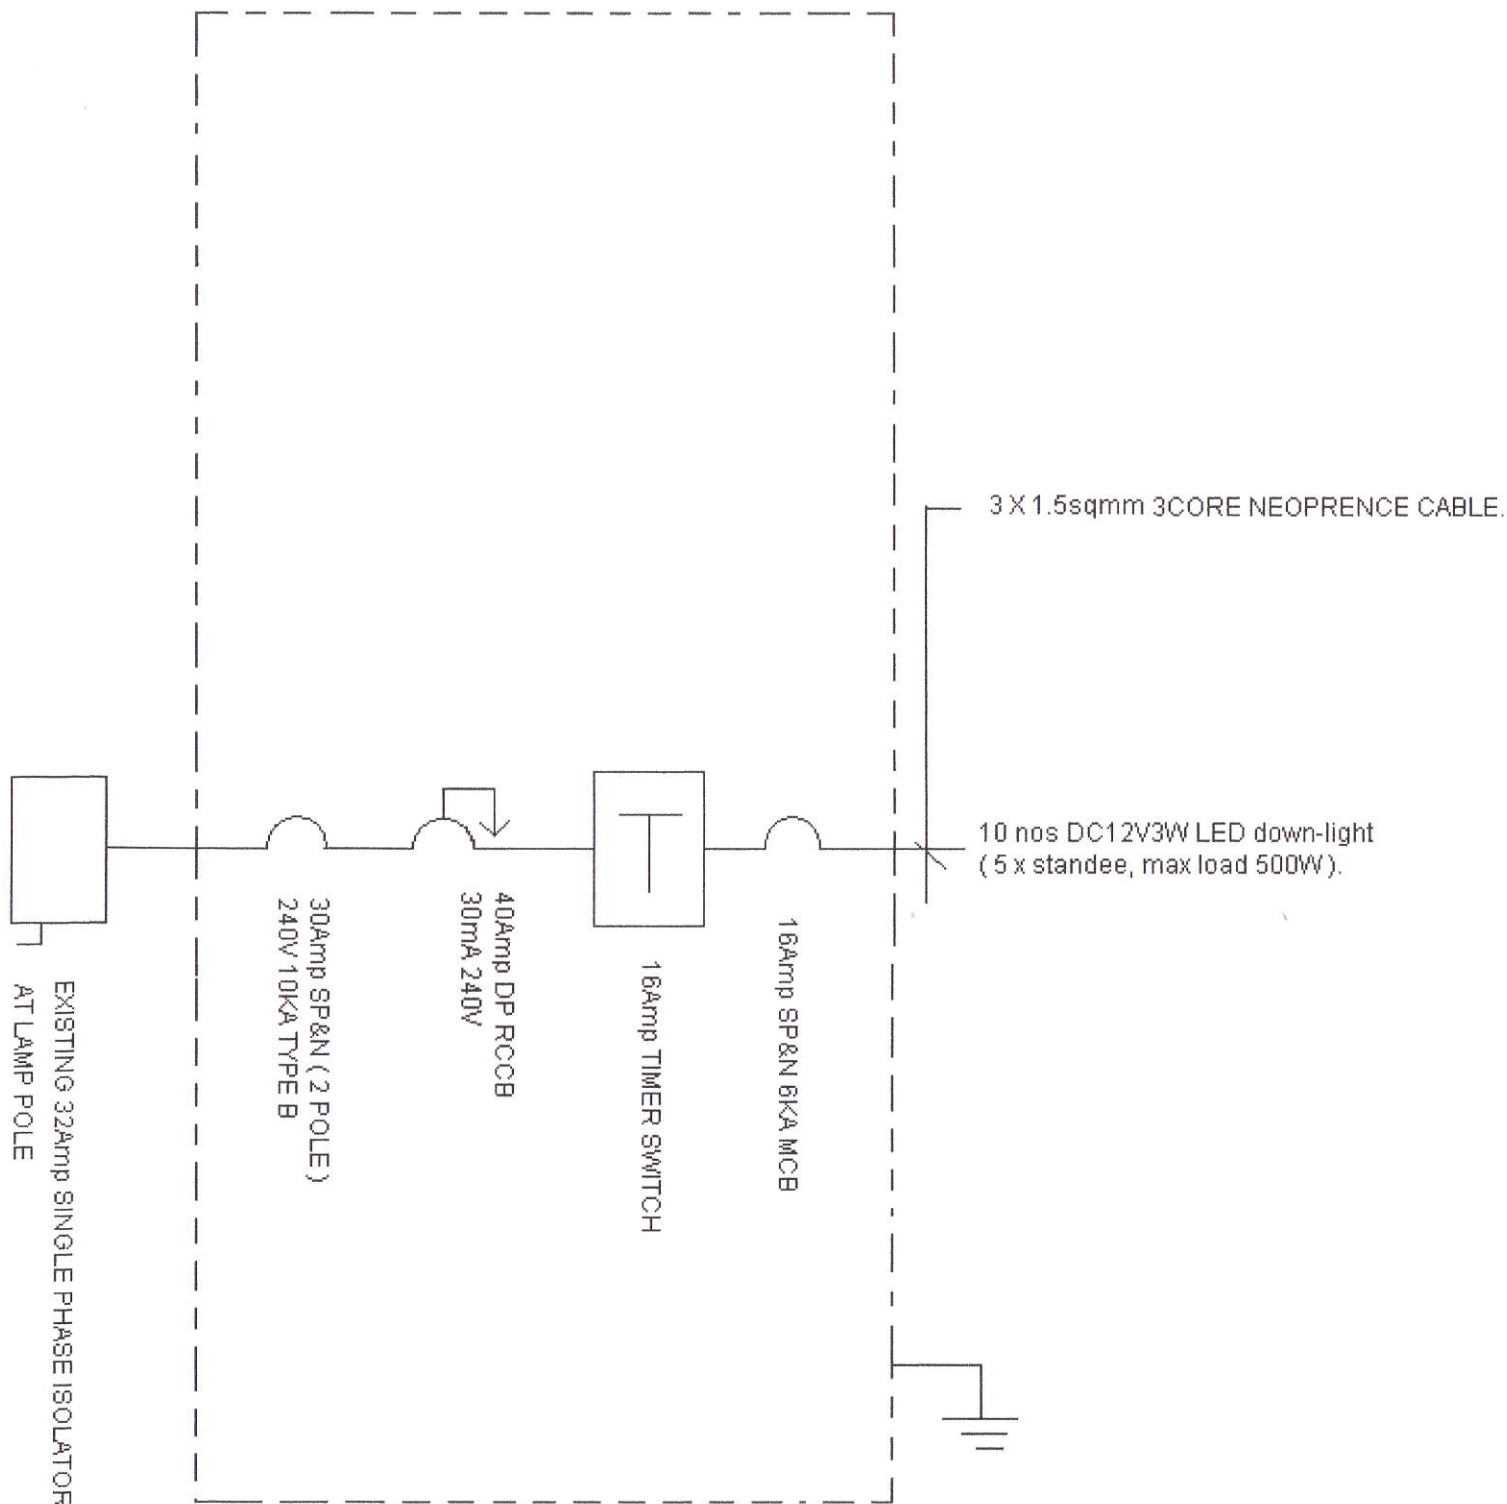

OWNER :

SPH MBO
1000 Toa Payoh North
News Centre S(318994)

PROJECT :

CANON FOCUS ON FASHION 2010

02 APRIL - 02 MAY 2010

LOCATION :

WHEELOCH^K PLACE OUT-DOOR AREA

ORCHARD ROAD

LICENSED ELECTRICAL WORKER :

Hosaini Bin Rasid
LEW No: 7/079776

[Signature]
11/03/2010

CONTRACTOR :

OGL ASIA PTE LTD
134 JOO SENG ROAD #01-03
NOBEL DESIGN HOUSE
SINGAPORE 368359
TEL : 6284 9011 FAX : 6284 9052

DRAWING :

ELECTRICAL SCHEMATIC
SINGLE LINE DIAGRAM

DRAWN :

MR. LOI

SCALE

NTS

CHECKED :


MR. NG

DATE :


11 MARCH 2010

DRAWING NO. :


CANON @ WHEELOCH PLACE OUT-DOOR 10 / E01

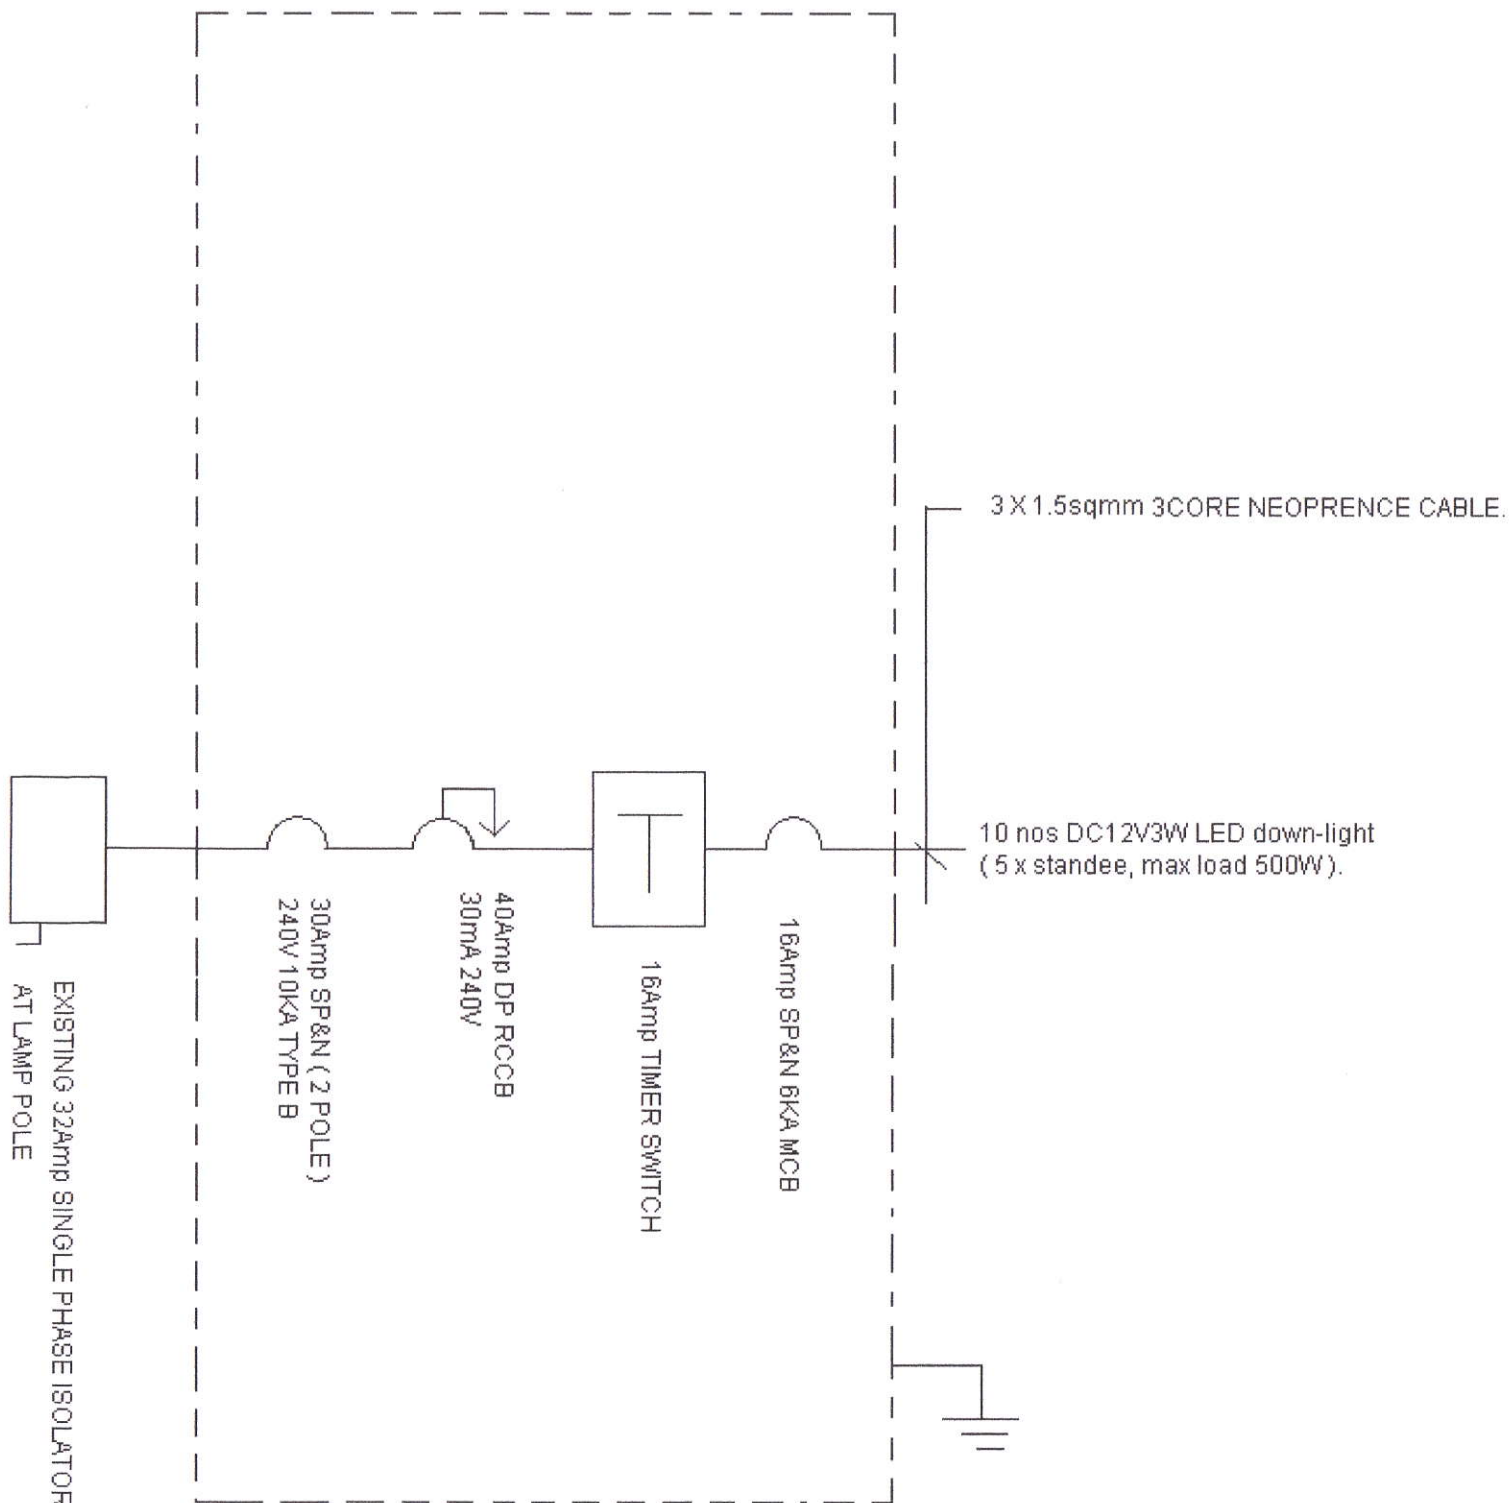

OWNER: SPHMB0 1000 Toa Payoh North News Centre S(318994)	
PROJECT: CANON FOCUS ON FASHION 2010 02 APRIL - 02 MAY 2010	
LOCATION: ION ORCHARD OUT-DOOR AREA ORCHARD ROAD	
LICENSED ELECTRICAL WORKER: Hosaini Bin Rasid LEW No: 71079776 11/03/2010	
CONTRACTOR: OGL ASIA PTE LTD 134 JOO SENG ROAD #01-03 NOBEL DESIGN HOUSE SINGAPORE 368359 TEL : 6284 9011 FAX : 6284 9052	
DRAWING : ELECTRICAL SCHEMATIC SINGLE LINE DIAGRAM	
DRAWN : MR. LOI	SCALE NTS
CHECKED : MR. NG	DATE: 11 MARCH 2010
DRAWING NO. : CANON @ ION ORCHARD OUT-DOOR 10 / E01	

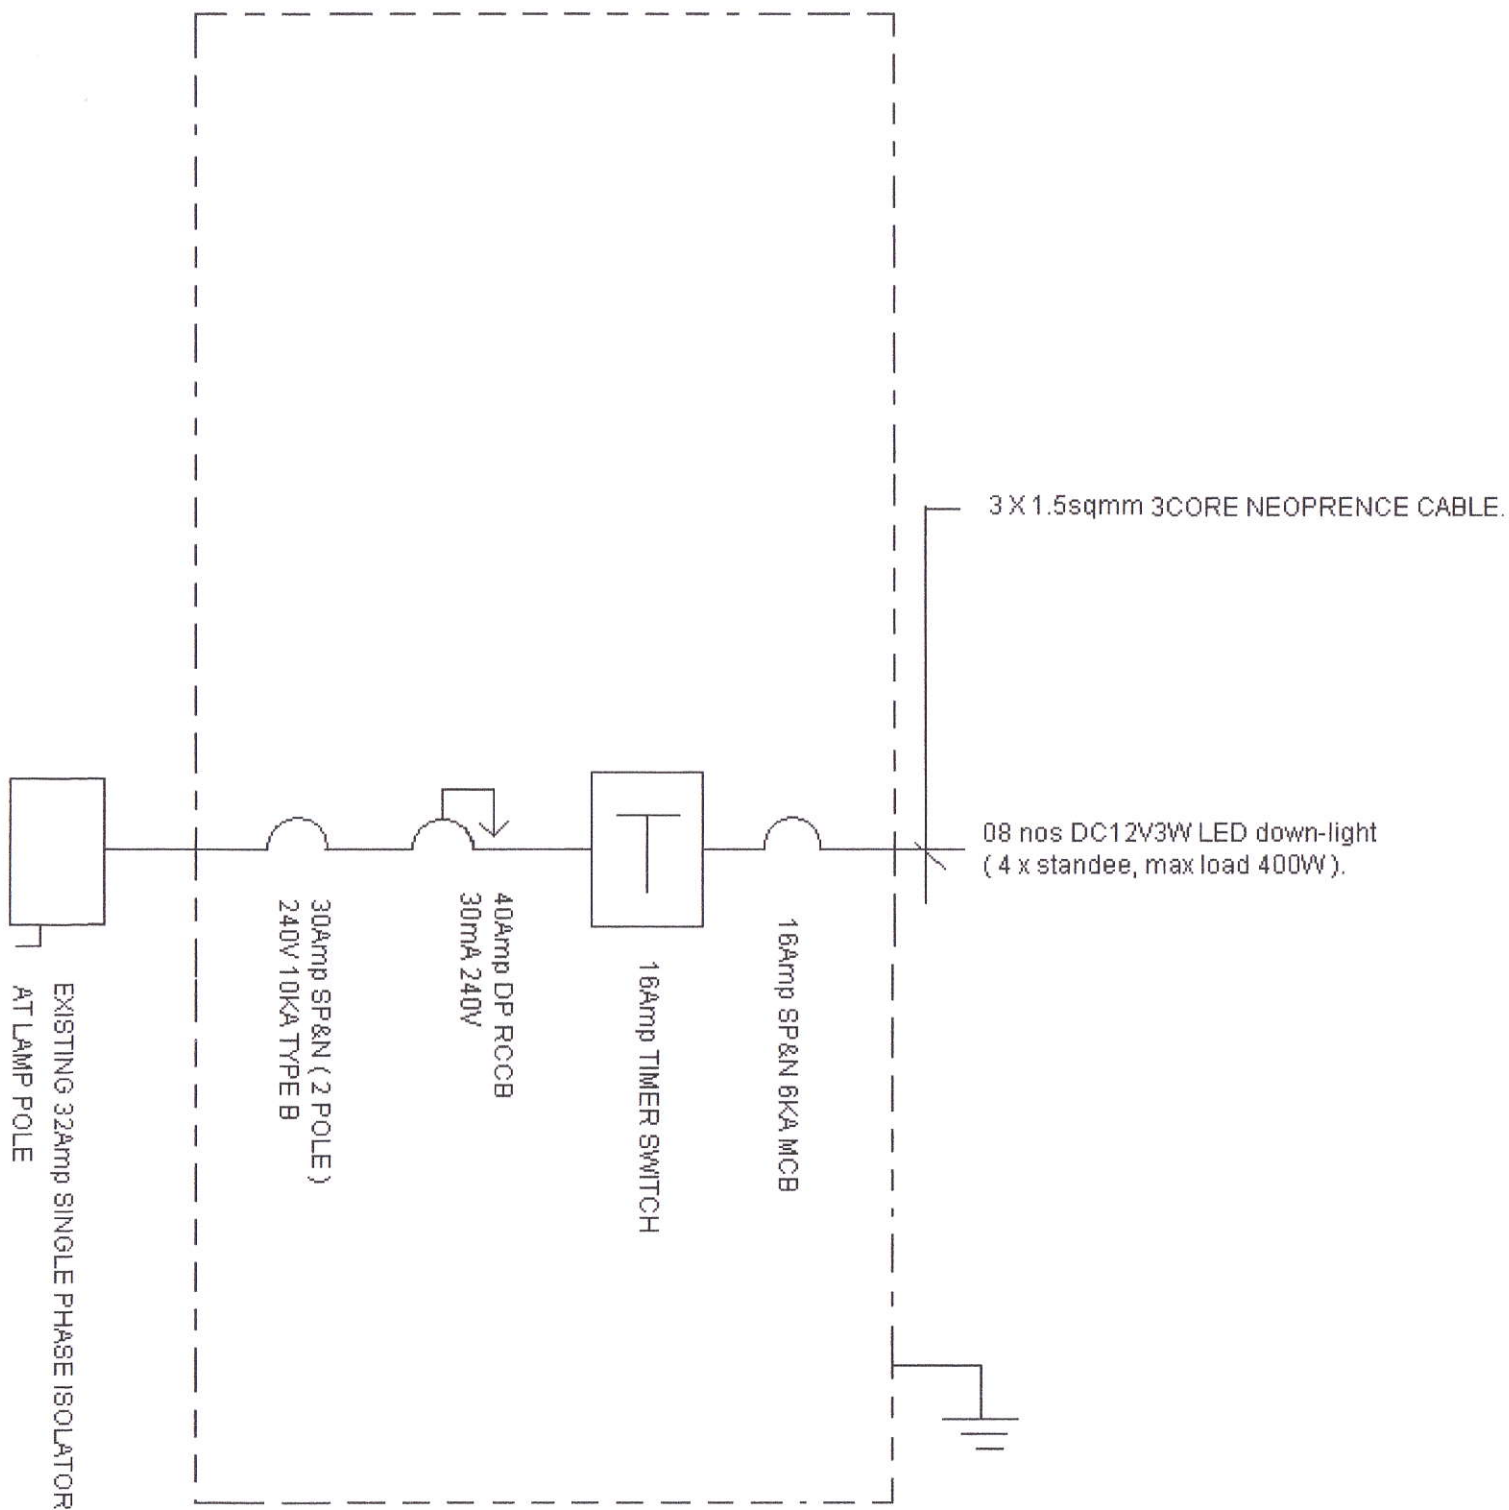

OWNER : SPH MBO 1000 Toa Payoh North News Centre S(318994)	
PROJECT : CANON FOCUS ON FASHION 2010 02 APRIL - 02 MAY 2010	
LOCATION : WISMA ATRIA OUT-DOOR AREA ORCHARD ROAD	
LICENSED ELECTRICAL WORKER : Hosaini Bin Rasid LEW No: 71079776 <i>11/03/2010</i>	
CONTRACTOR : OGL ASIA PTE LTD 134 JOO SENG ROAD #01-03 NOBEL DESIGN HOUSE SINGAPORE 368359 TEL : 6284 9011 FAX : 6284 9052	
DRAWING : ELECTRICAL SCHEMATIC SINGLE LINE DIAGRAM	
DRAWN : MR. LOI	SCALE NTS
CHECKED : MR. NG	DATE : 11 MARCH 2010
DRAWING NO. : CANON @ WISMA ATRIA OUT-DOOR 10 / E 01	

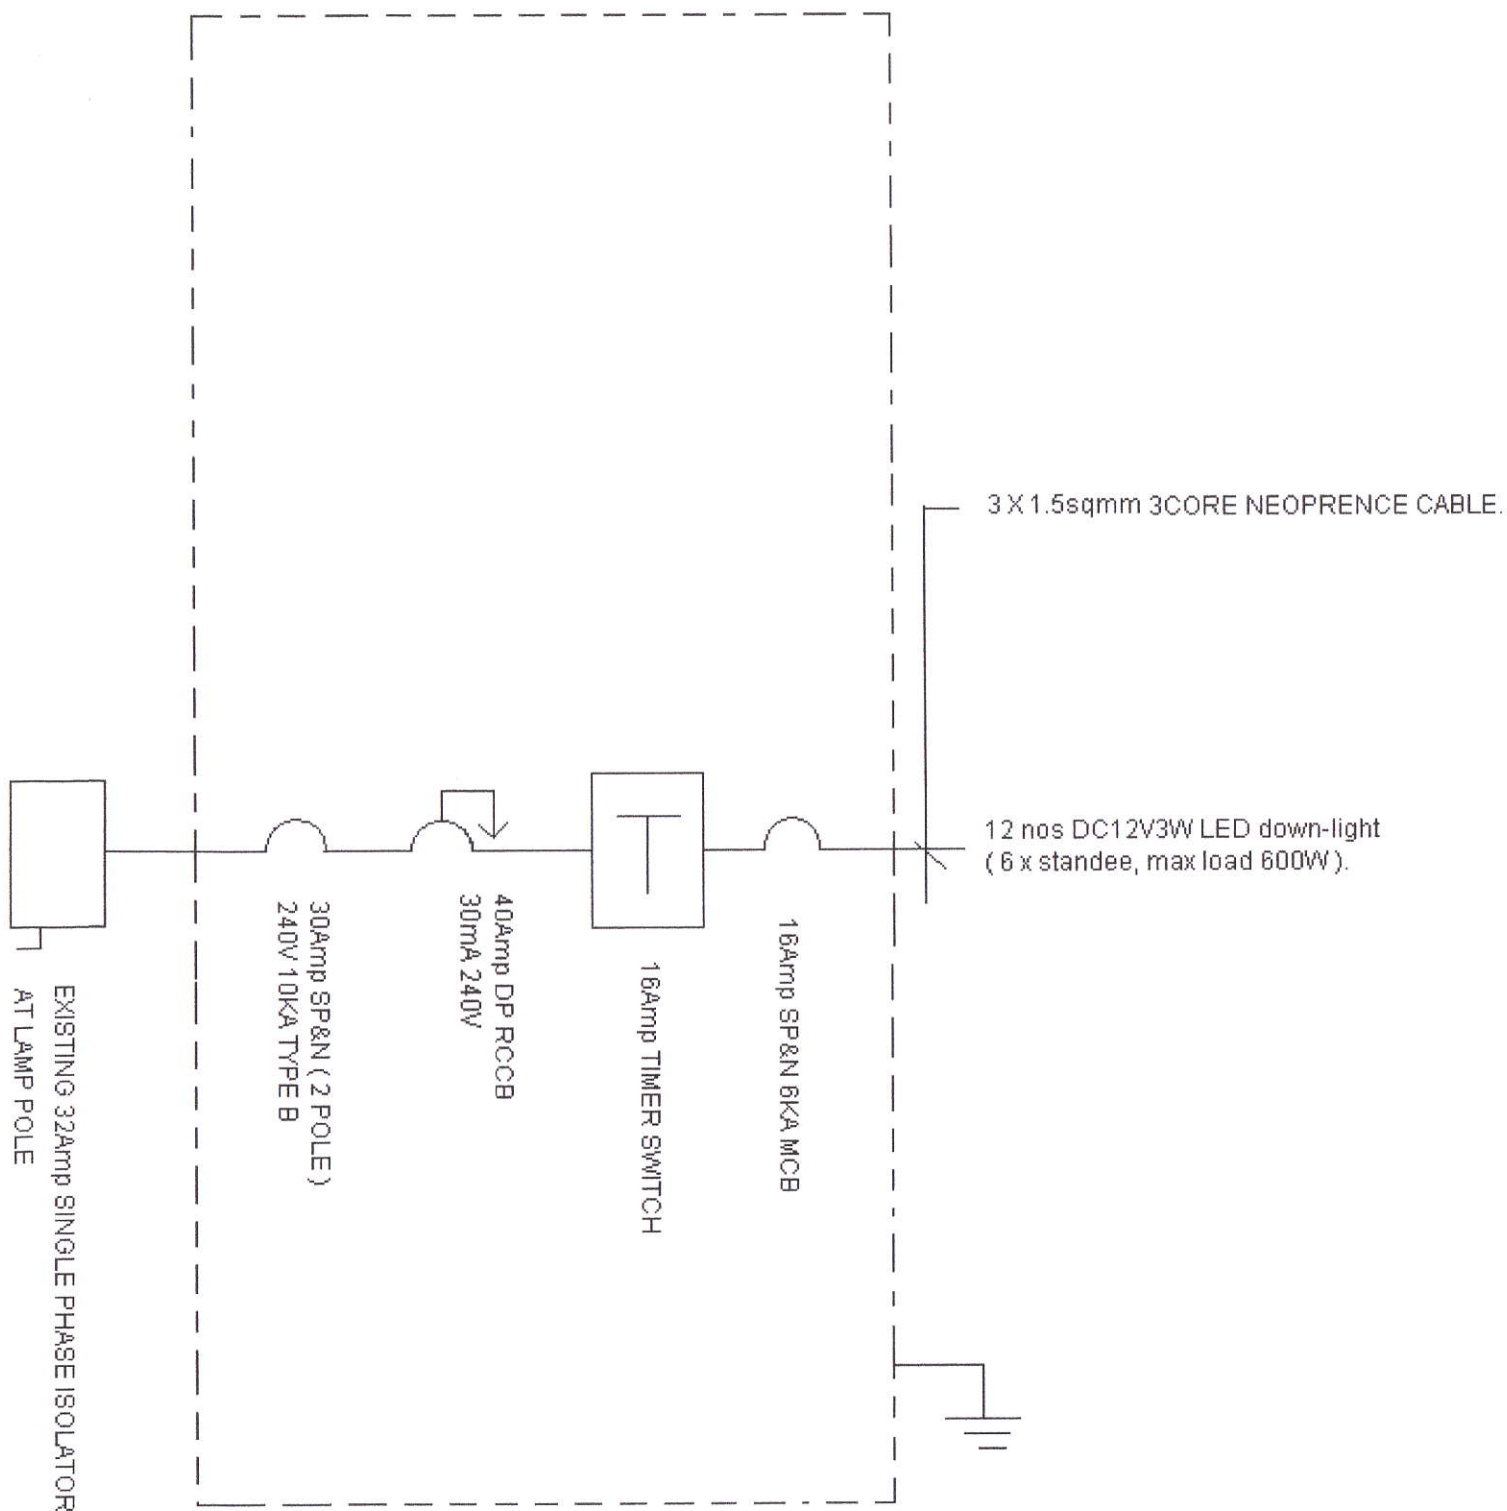

OWNER :

SPH MBO
1000 Toa Payoh North
News Centre S(318994)

PROJECT :

CANON FOCUS ON FASHION 2010

02 APRIL - 02 MAY 2010

LOCATION :

NGEE ANN CITY OUT-DOOR AREA

ORCHARD ROAD

LICENSED ELECTRICAL WORKER :

Hosain Bin Rasid
LEW No: 71079776

[Signature]
11/03/2010

CONTRACTOR :

OGL ASIA PTE LTD
134 JOO SENG ROAD #01-03
NOBEL DESIGN HOUSE
SINGAPORE 368359
TEL : 6284 9011 FAX : 6284 9052

DRAWING :

ELECTRICAL SCHEMATIC
SINGLE LINE DIAGRAM

DRAWN :

MR. LOI

SCALE

NTS

CHECKED :


MR. NG

DATE :

11 MARCH 2010

DRAWING NO. :

CANON @ Ngee Ann City Out-Door 10 / E 01

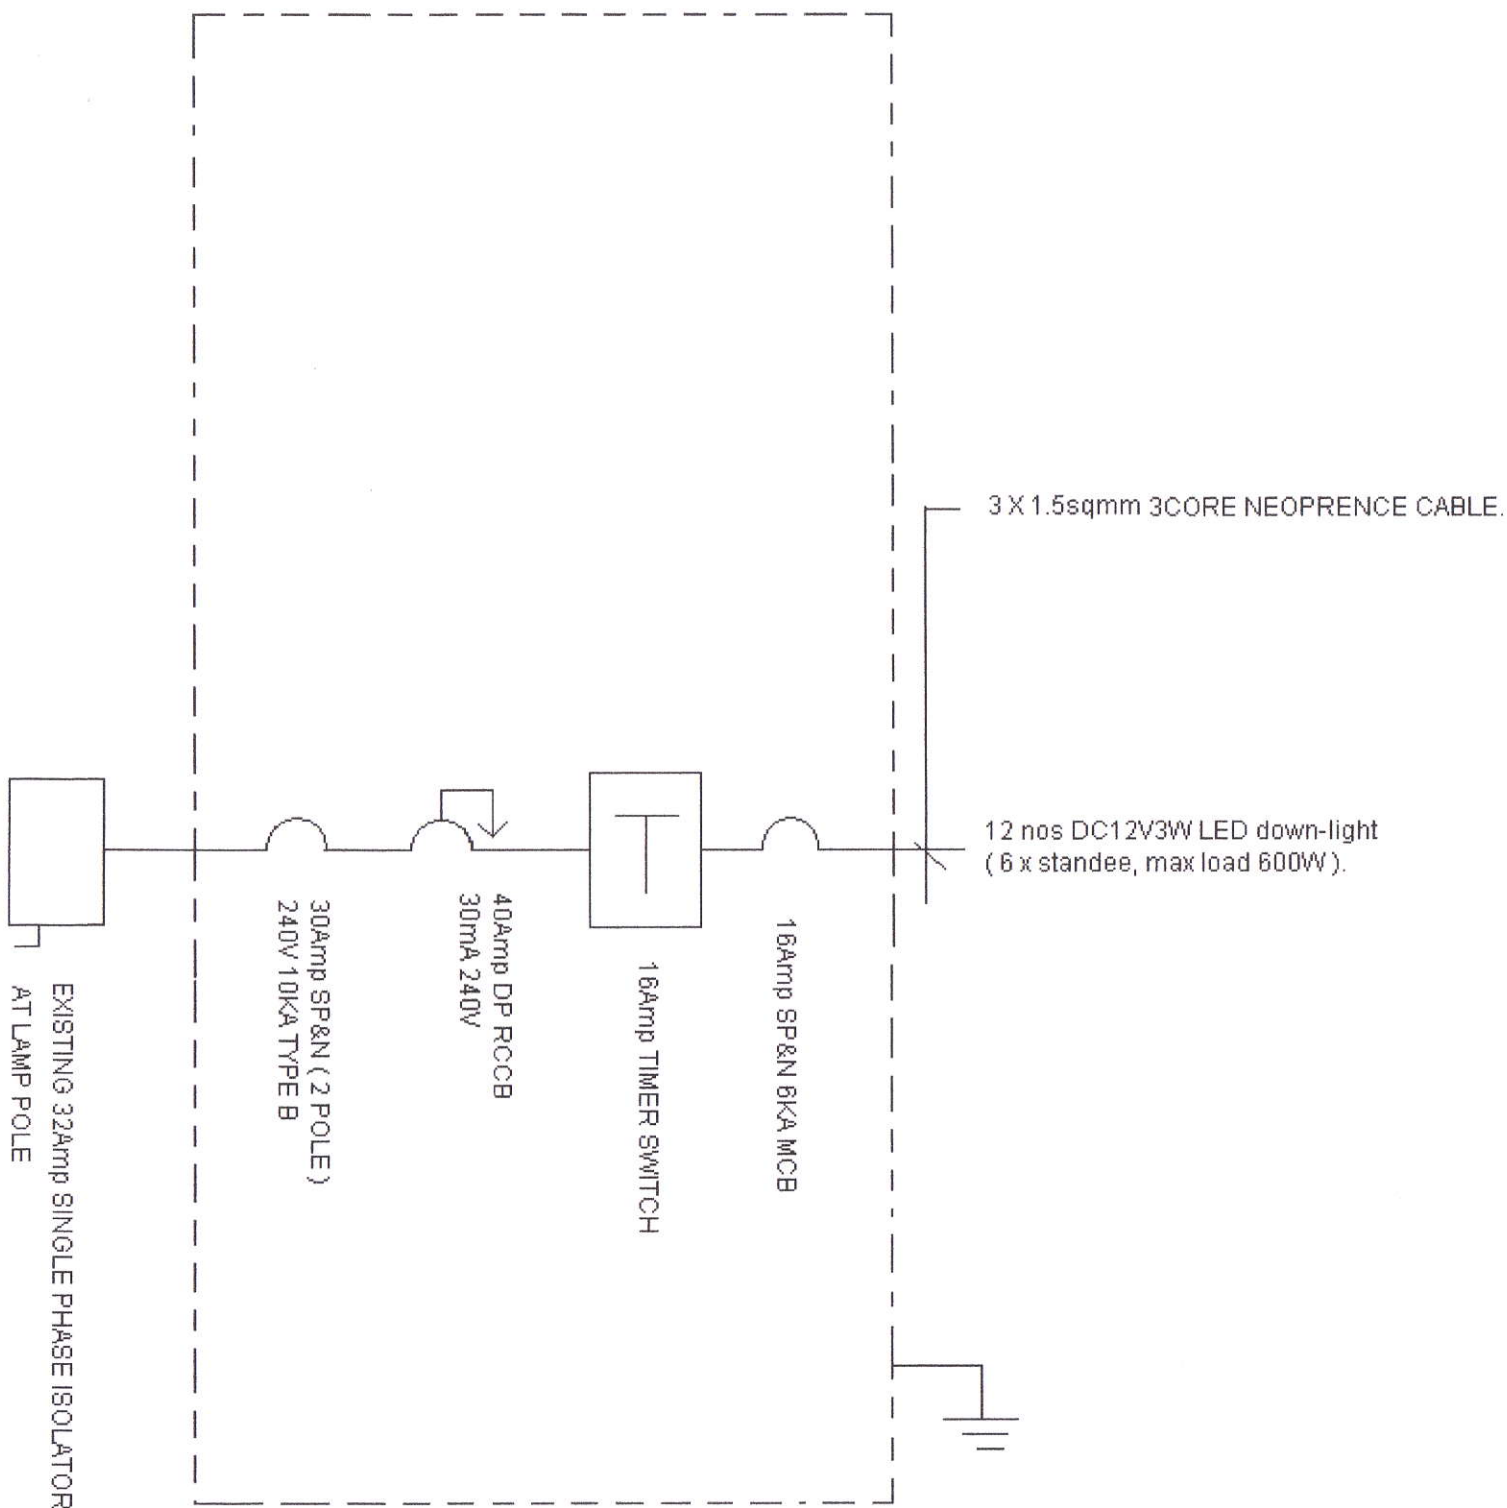

OWNER :

SPH M80
1000 Toa Payoh North
News Centre S(318994)

PROJECT :

CANON FOCUS ON FASHION 2010

02 APRIL - 02 MAY 2010

LOCATION :

MANDARIN GALLERY OUT-DOOR AREA
ORCHARD ROAD

LICENSED ELECTRICAL WORKER :

Hosany bin KASIM
LEW No: 71079776

11/03/2010

CONTRACTOR :

OGL ASIA PTE LTD
134 JOO SENG ROAD #01-03
NOBEL DESIGN HOUSE
SINGAPORE 368359
TEL : 6284 9011 FAX : 6284 9052

DRAWING :

ELECTRICAL SCHEMATIC
SINGLE LINE DIAGRAM

DRAWN :

MR. LOI

SCALE

NTS

CHECKED :


MR. NG

DATE :


11 MARCH 2010


DRAWING NO. :


CANON @ MANDARIN GALLERY 10 / E01

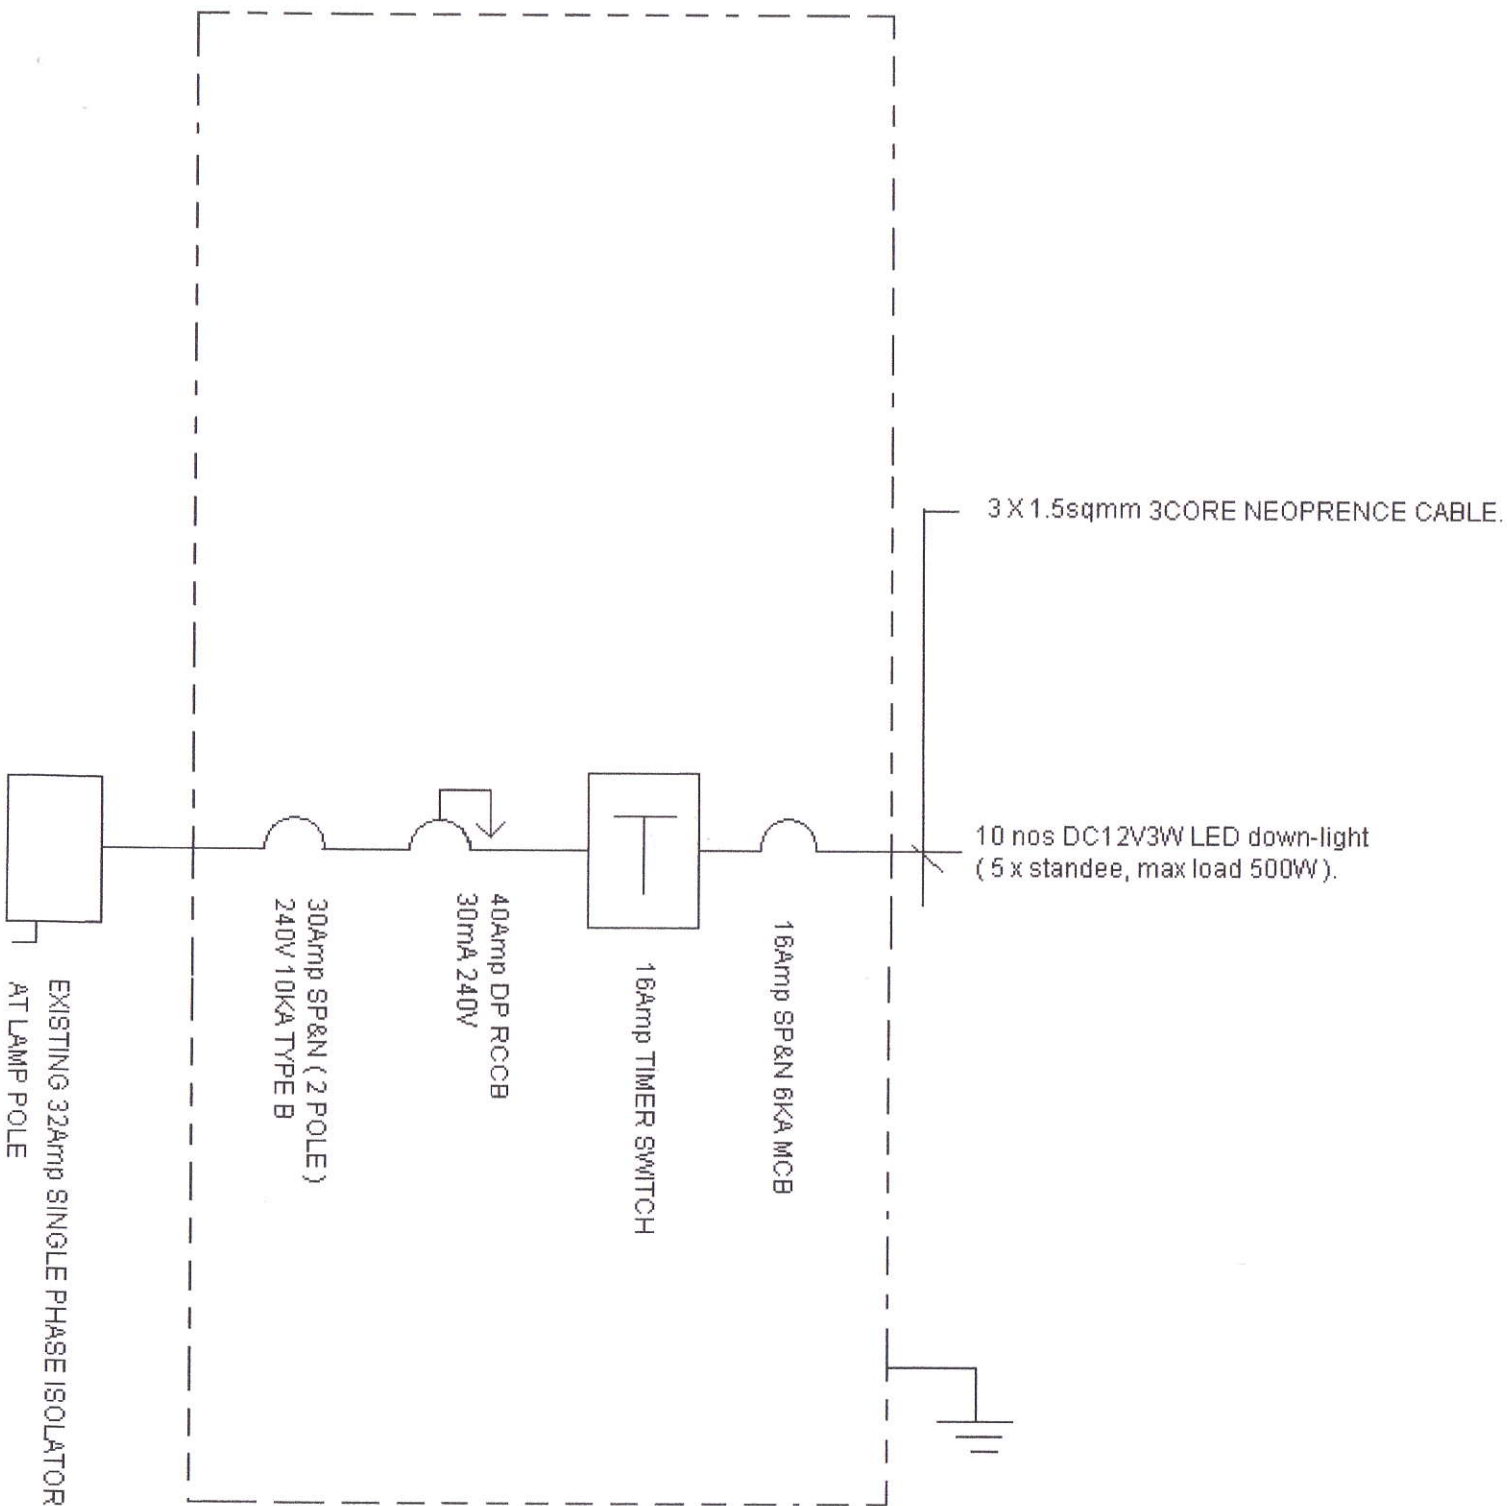

OWNER : SPHMB0 1000 Toa Payoh North News centre S(318994)	
PROJECT : CANON FOCUS ON FASHION 2010 02 APRIL - 02 MAY 2010	
LOCATION : HEEREN OUT-DOOR AREA ORCHARD ROAD	
LICENSED ELECTRICAL WORKER : Hosaini Bin Rasid LEW No: 71079776 11/03/2010	
CONTRACTOR : OGL ASIA PTE LTD 134 JOO SENG ROAD #01-03 NOBEL DESIGN HOUSE SINGAPORE 368359 TEL : 6284 9011 FAX : 6284 9052	
DRAWING : ELECTRICAL SCHEMATIC SINGLE LINE DIAGRAM	
DRAWN : MR. LOI	SCALE NTS
CHECKED : MR. NG	DATE : 11 MARCH 2010
DRAWING NO. : CANON @ HEEREN OUT-DOOR 10 / E 01	

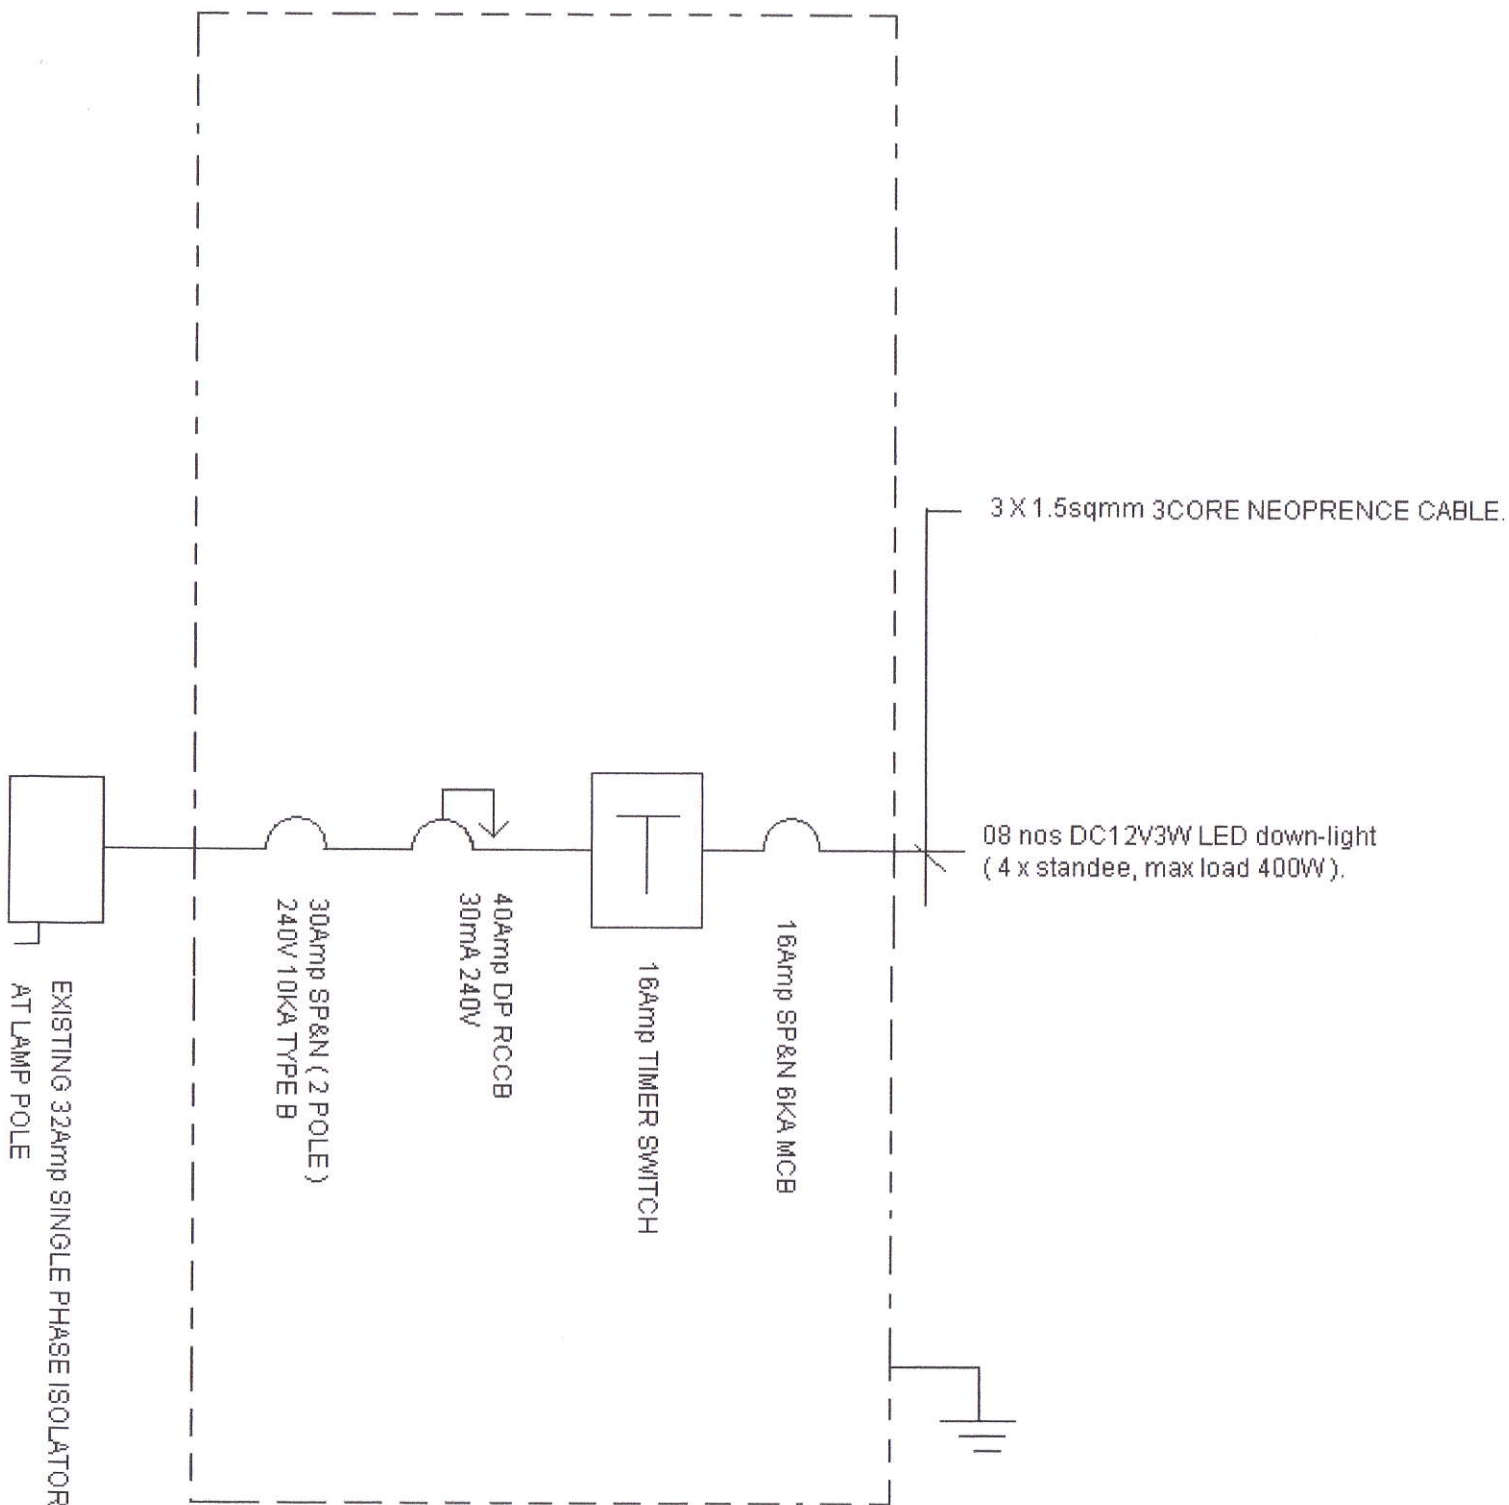

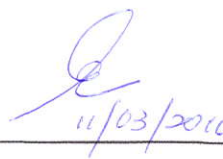OWNER: SPH M30 1000 Toa Payoh North News Centre S(318994)	
PROJECT: CANON FOCUS ON FASHION 2010 02 APRIL - 02 MAY 2010	
LOCATION: CENTREPOINT OUT-DOOR AREA ORCHARD ROAD	
LICENSED ELECTRICAL WORKER: Hosain Bin Rasid LEW No: 7/079776  11/03/2010	
CONTRACTOR: OGL ASIA PTE LTD 134 JOO SENG ROAD #01-03 NOBEL DESIGN HOUSE SINGAPORE 368359 TEL : 6284 9011 FAX : 6284 9052	
DRAWING: ELECTRICAL SCHEMATIC SINGLE LINE DIAGRAM	
DRAWN: MR. LOI	SCALE NTS
CHECKED: MR. NG	DATE: 11 MARCH 2010
DRAWING NO.: CANON @ CENTREPOINT OUT-DOOR 10 / E 01	

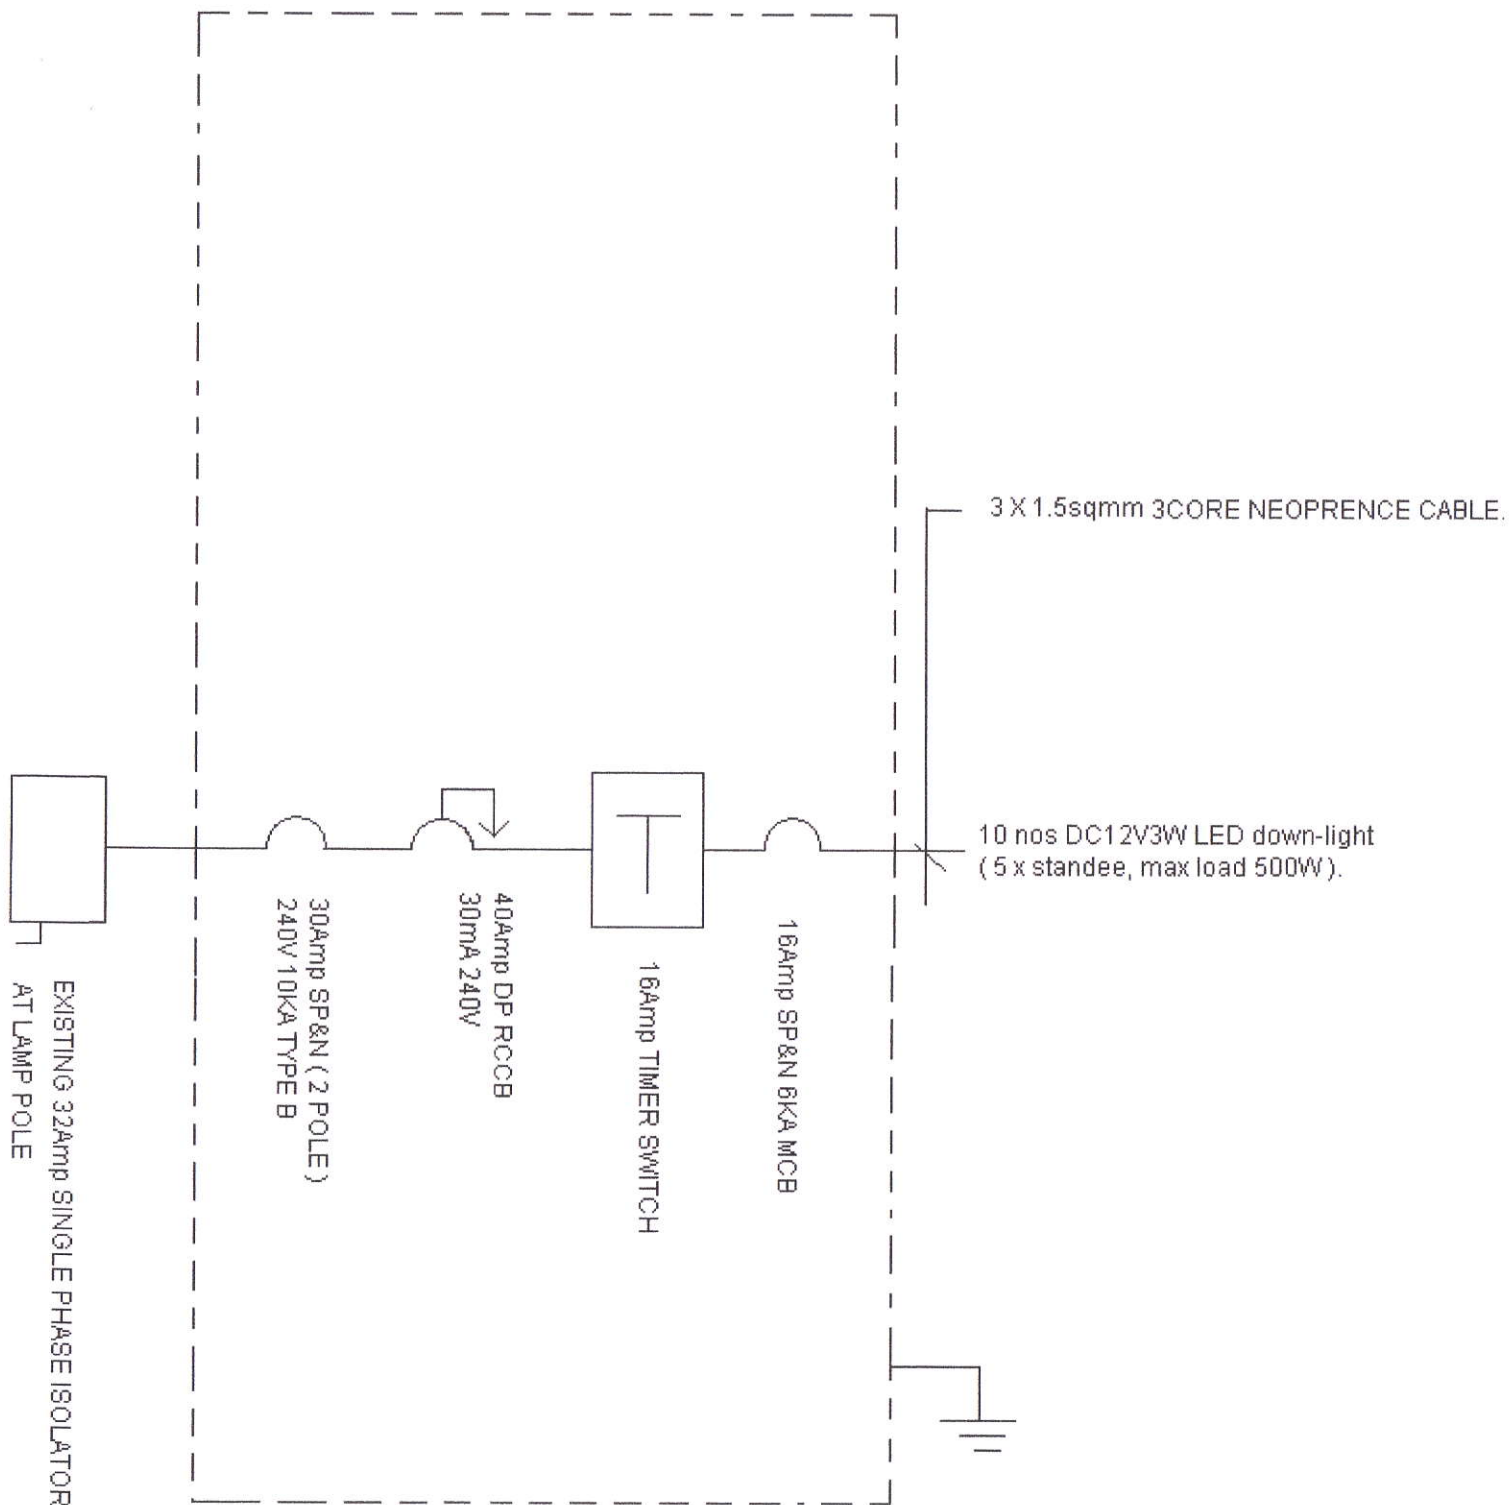

OWNER :

SPHIMBO
1000 Toa Payoh North
News Centre S(318994)

PROJECT :

CANON FOCUS ON FASHION 2010

02 APRIL - 02 MAY 2010

LOCATION :

313 @ SOMERSET OUT-DOOR AREA
ORCHARD ROAD

LICENSED ELECTRICAL WORKER :

Hosaini Bin Rasid
LEW No: 71079776

[Signature]
11/03/2010

CONTRACTOR :

OGL ASIA PTE LTD
134 JOO SENG ROAD #01-03
NOBEL DESIGN HOUSE
SINGAPORE 368359
TEL : 6284 9011 FAX : 6284 9052

DRAWING :

ELECTRICAL SCHEMATIC
SINGLE LINE DIAGRAM

DRAWN :

MR. LOI

SCALE

NTS

CHECKED :


MR. NG

DATE :

11 MARCH 2010

DRAWING NO. :

CANON @ 313@SOMERSET 10 / E01

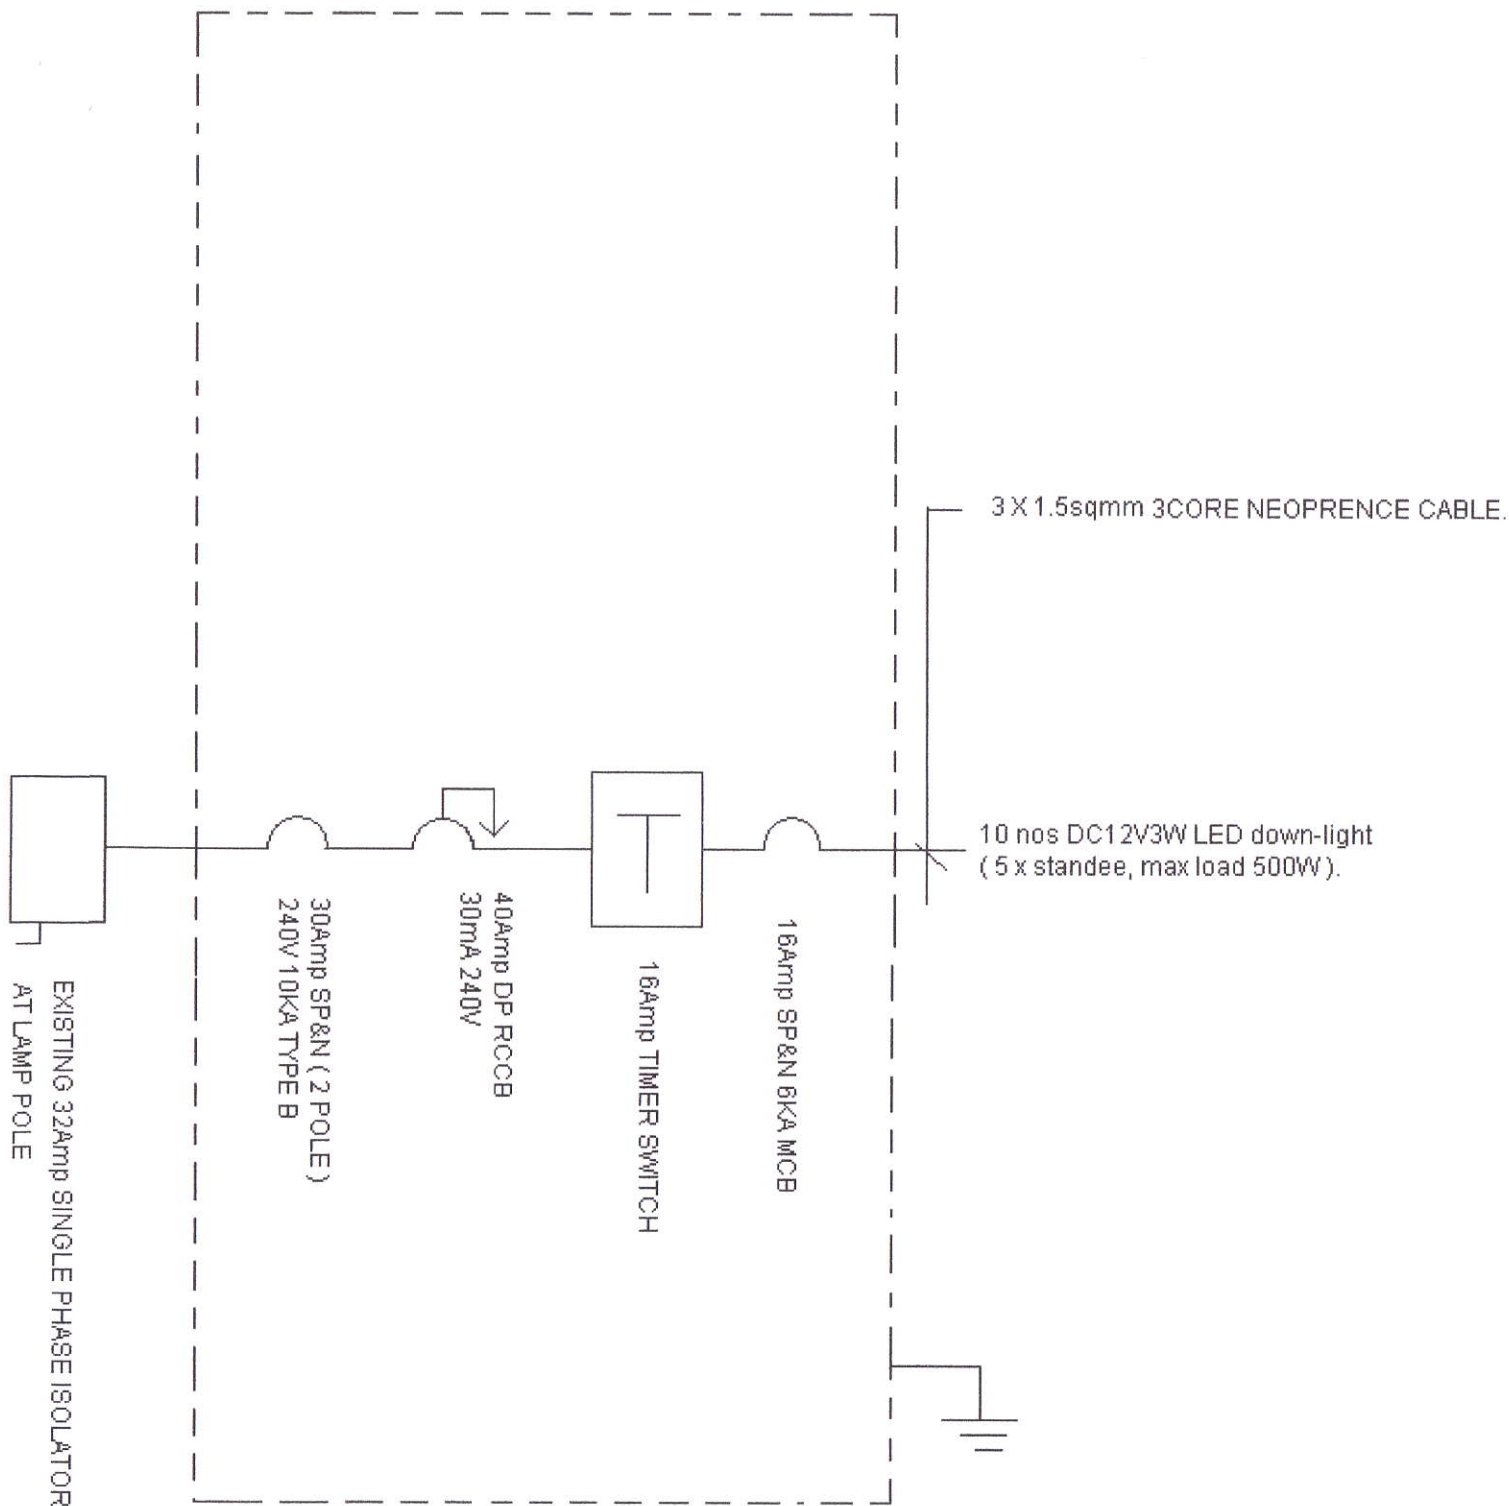

OWNER :

SPHMB0
1000 Toa Payoh North
News Centre S(318994)

PROJECT :

CANON FOCUS ON FASHION 2010

02 APRIL - 02 MAY 2010

LOCATION :

ORCHARD CENTRAL OUT-DOOR AREA
ORCHARD ROAD

LICENSED ELECTRICAL WORKER :

Hosain Bin Rasid
LEW No: 71079776

[Signature]
14/03/2010

CONTRACTOR :

OGL ASIA PTE LTD
134 JOO SENG ROAD #01-03
NOBEL DESIGN HOUSE
SINGAPORE 368359
TEL : 6284 9011 FAX : 6284 9052

DRAWING :

ELECTRICAL SCHEMATIC
SINGLE LINE DIAGRAM

DRAWN :

MR. LOI

SCALE

NTS

CHECKED :

MR. NG

DATE :

11 MARCH 2010

DRAWING NO. :

CANON @ ORCHARD CENTRAL 10 / E01